

**NOTES BY SYMBOL**  
 1 4" DIA VENT TRAP AND PROSET TRAP GLAIVED UP TO FLOOR FINISH

	30.9 FT	
	196.0 FT	
	12.2 FT	
	1.0 EA	
	1.0 EA	
	1.0 EA	
	12.0 FT	
	12.0 FT	

**DIR Group**  
Construction Documents


**TELIOS**  
 engineering

**EAST 7TH STREET**  
10000 E. 7TH STREET  
 AUSTIN, TEXAS 78750

**CONSTRUCTION DOCUMENTS**  
 REVISIONS  
 1 01/20/2024 08:00:00  
 2 01/20/2024 08:00:00

30-22750-00  
 BASEMENT 02  
 UNDERFLOOR  
 PLUMBING PLAN  
 P-2B0



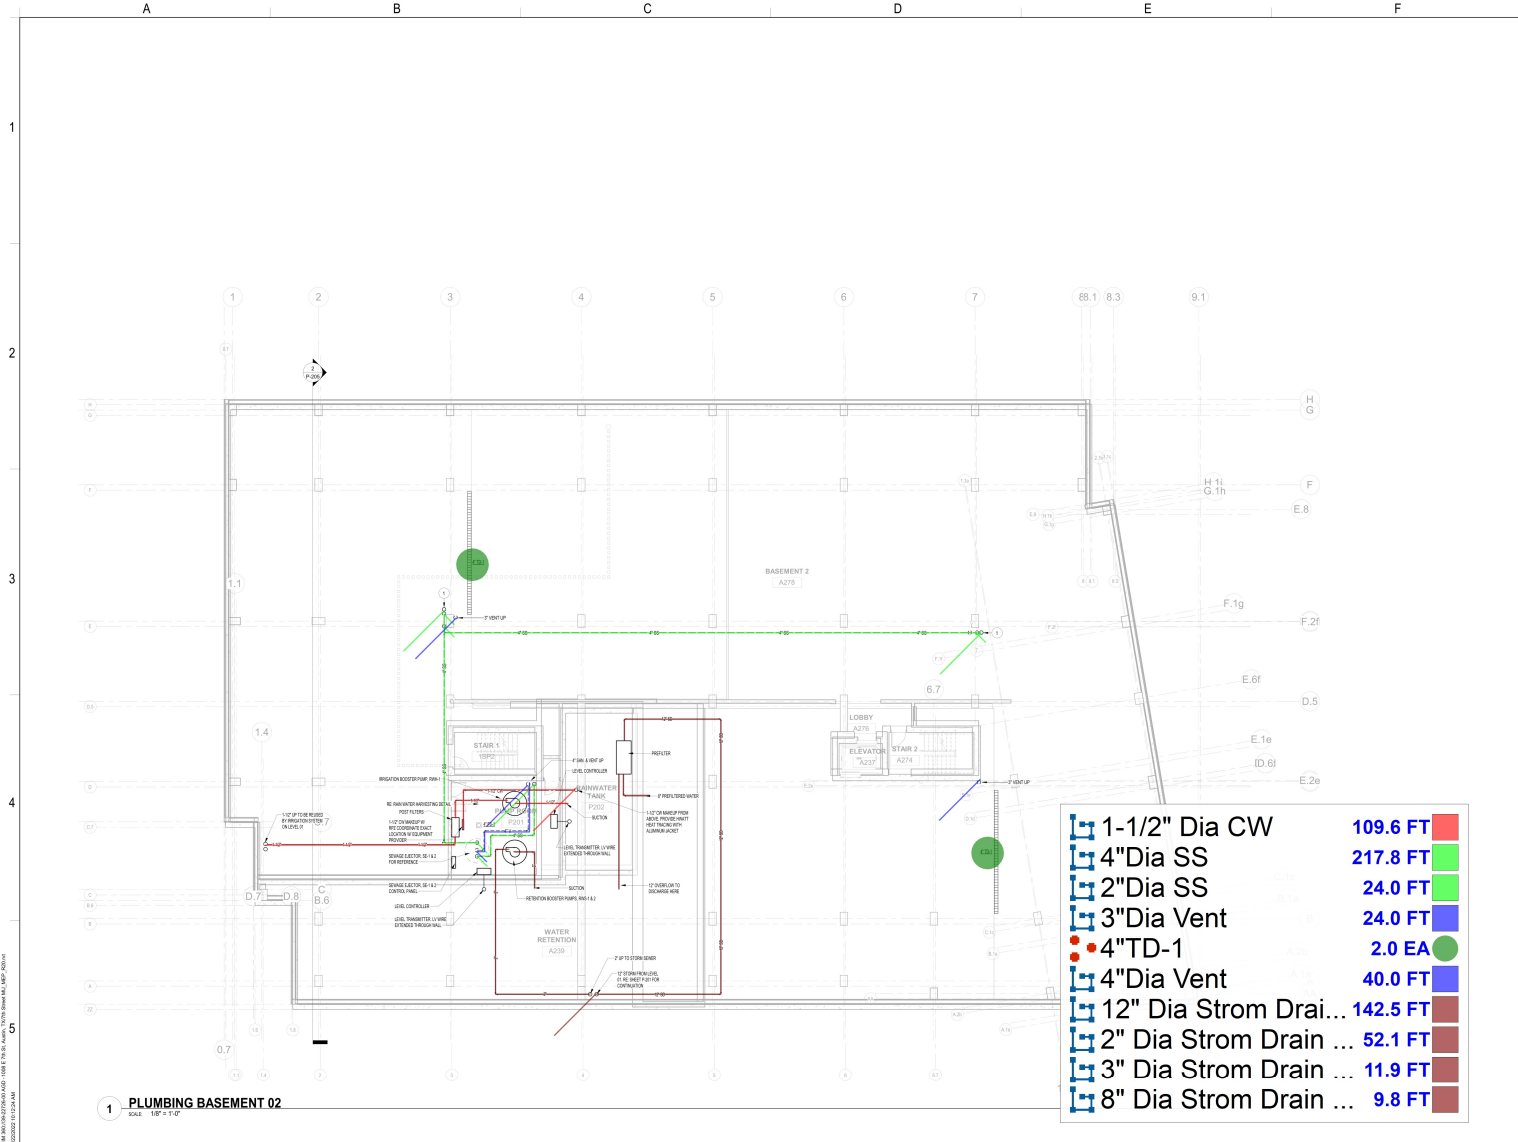

1-1/2" Dia CW	109.6 FT
4" Dia SS	217.8 FT
2" Dia SS	24.0 FT
3" Dia Vent	24.0 FT
4" TD-1	2.0 EA
4" Dia Vent	40.0 FT
12" Dia Storm Drain	142.5 FT
2" Dia Storm Drain	52.1 FT
3" Dia Storm Drain	11.9 FT
8" Dia Storm Drain	9.8 FT

**1 PLUMBING BASEMENT 02**  
SCALE: 1/8" = 1'-0"

**DJR Group**  
Civil & Mechanical


**TELIOS**  
engineering

EAST 7TH STREET


CONSTRUCTION DOCUMENTS

30-22756-01  
PLUMBING PLAN  
BASEMENT 02

P-2B2

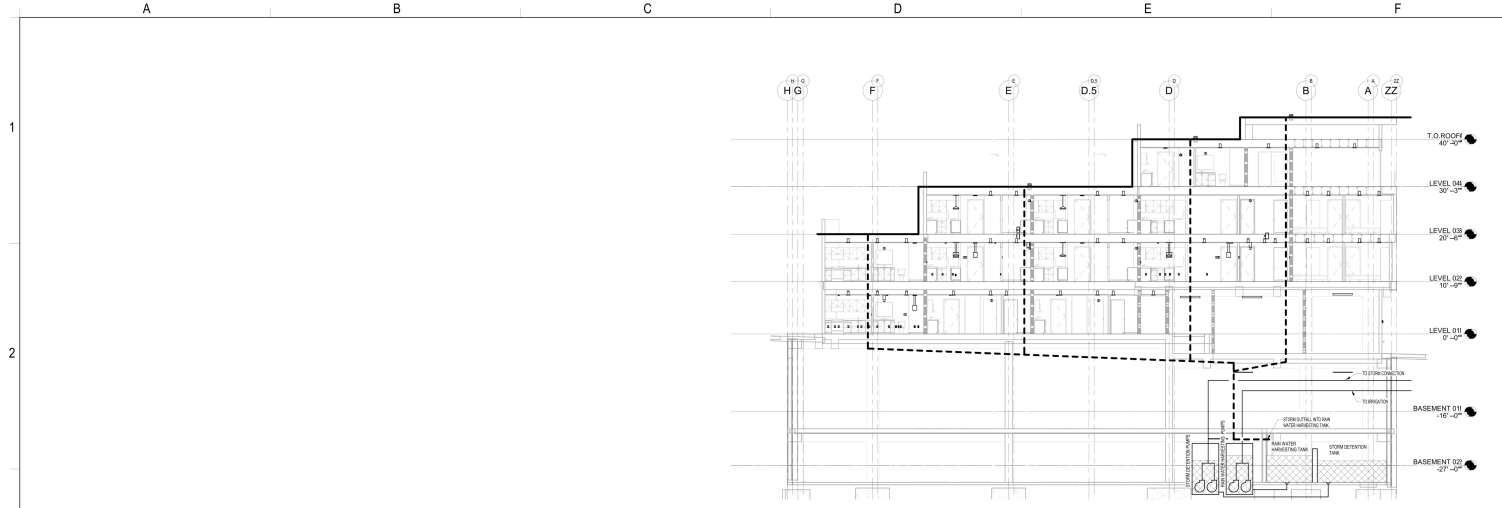

2 Section 2  
SCALE: 1/8" = 1'-0"

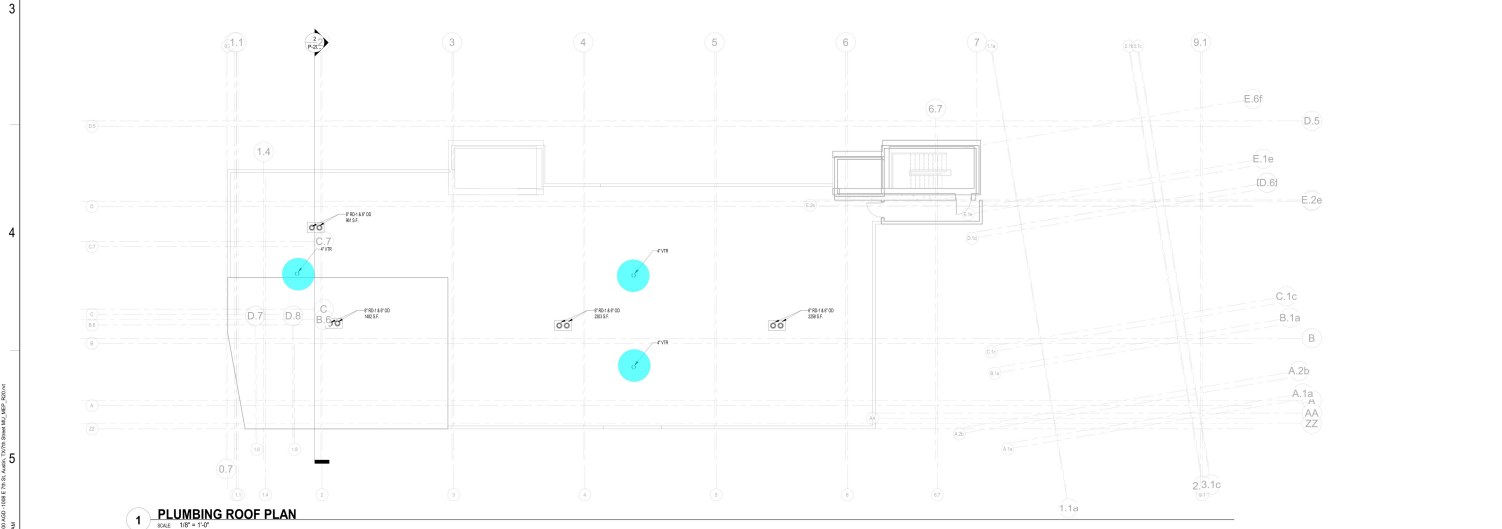

1 PLUMBING ROOF PLAN  
SCALE: 1/8" = 1'-0"

4" VTR 3.0 EA







10/11/2023 10:27:40 AM 10/11/2023 10:27:40 AM 10/11/2023 10:27:40 AM 10/11/2023 10:27:40 AM 10/11/2023 10:27:40 AM 10/11/2023 10:27:40 AM 10/11/2023 10:27:40 AM 10/11/2023 10:27:40 AM 10/11/2023 10:27:40 AM 10/11/2023 10:27:40 AM

**DLR Group**  
CONSULTING ENGINEERS

Professional Engineer  
State of Texas  
No. 123456789  
Exp. 12/31/2024

**TELIOS**  
engineering

**EAST 7TH STREET**

CONSTRUCTION DOCUMENTS

REVISIONS

DATE


BY

FOR

30-22758-00

PLUMBING UNIT PLANS

P-207

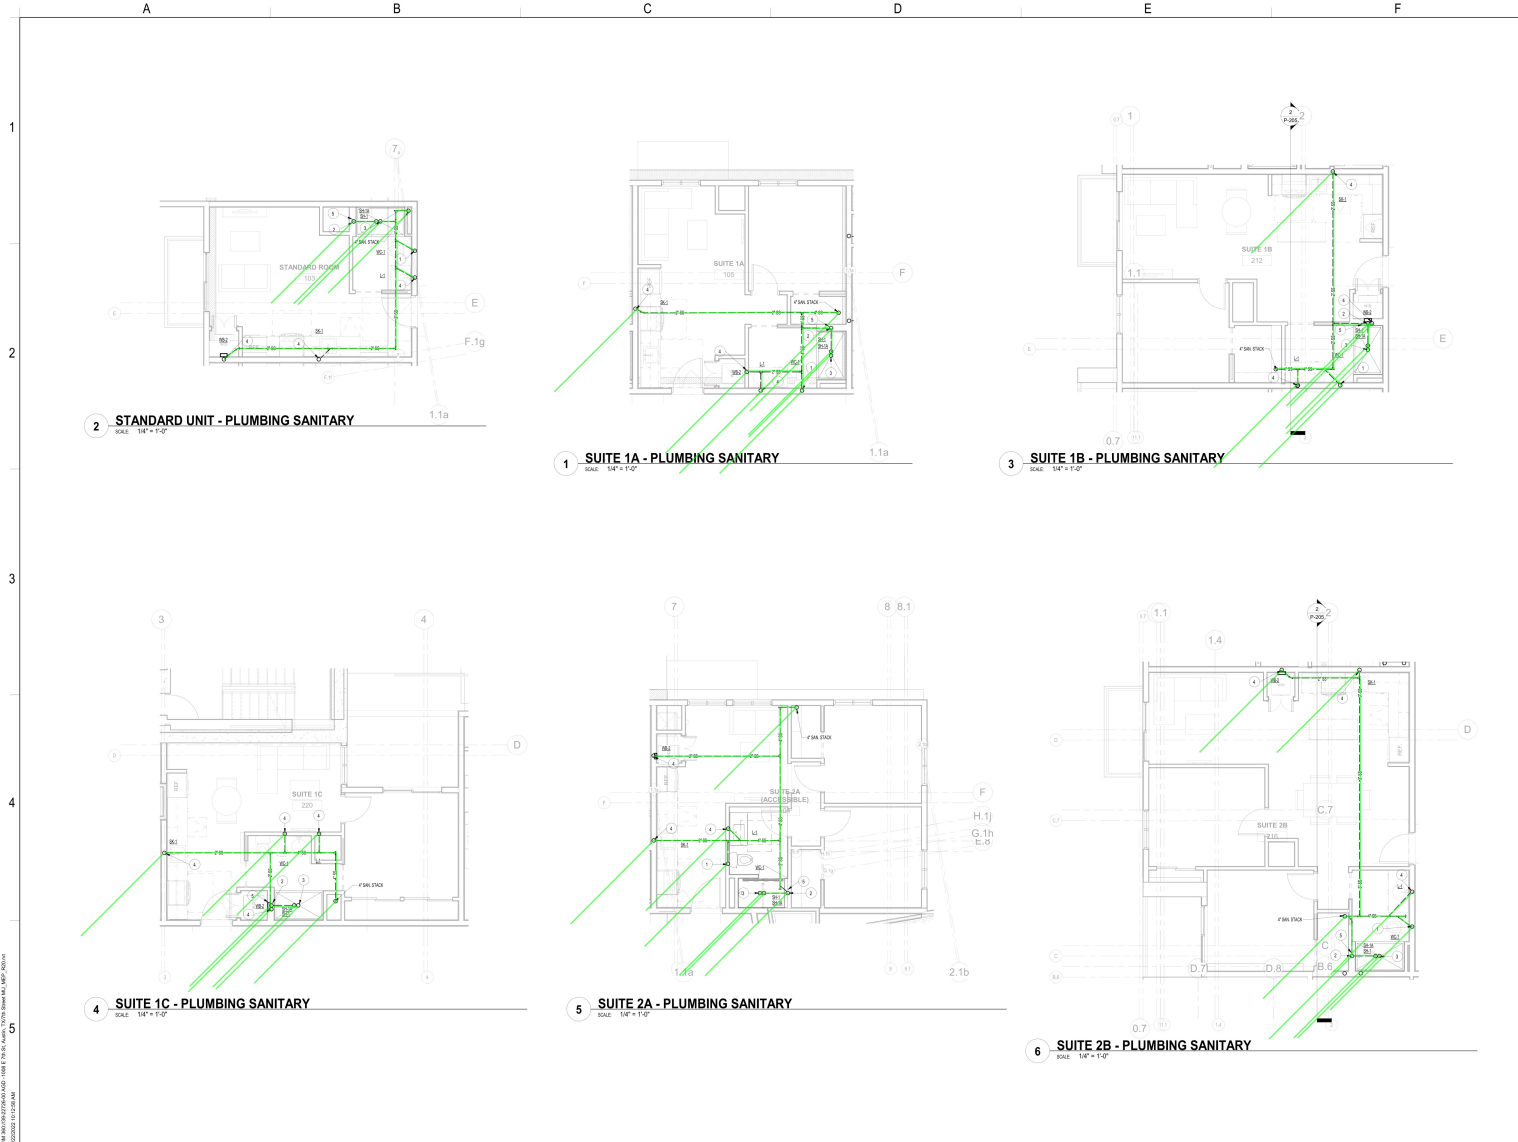

1848 E. 7th St., Austin, TX 78702, 512.476.1000  
 1848 E. 7th St., Austin, TX 78702, 512.476.1000  
 1848 E. 7th St., Austin, TX 78702, 512.476.1000

